

BRIAN D. WOLFE, AIA
FL LICENSE NO. AR 0010417
813.282.3500 FAX 813.288-0188
5100 W. KENNEDY BOULEVARD, SUITE 150
TAMPA, FLORIDA 33609

PROJECT NAME

RICHARD & KIM
MARKHAM

TAMPA, FL

CONSULTANT

SHEET TITLE

PLUMBING
PLAN

SEAL

DATE


SEPT 18, 2000

REVISIONS

SHEET NO.

A-6
7 OF 9

ISSUED FOR CONSTRUCTION

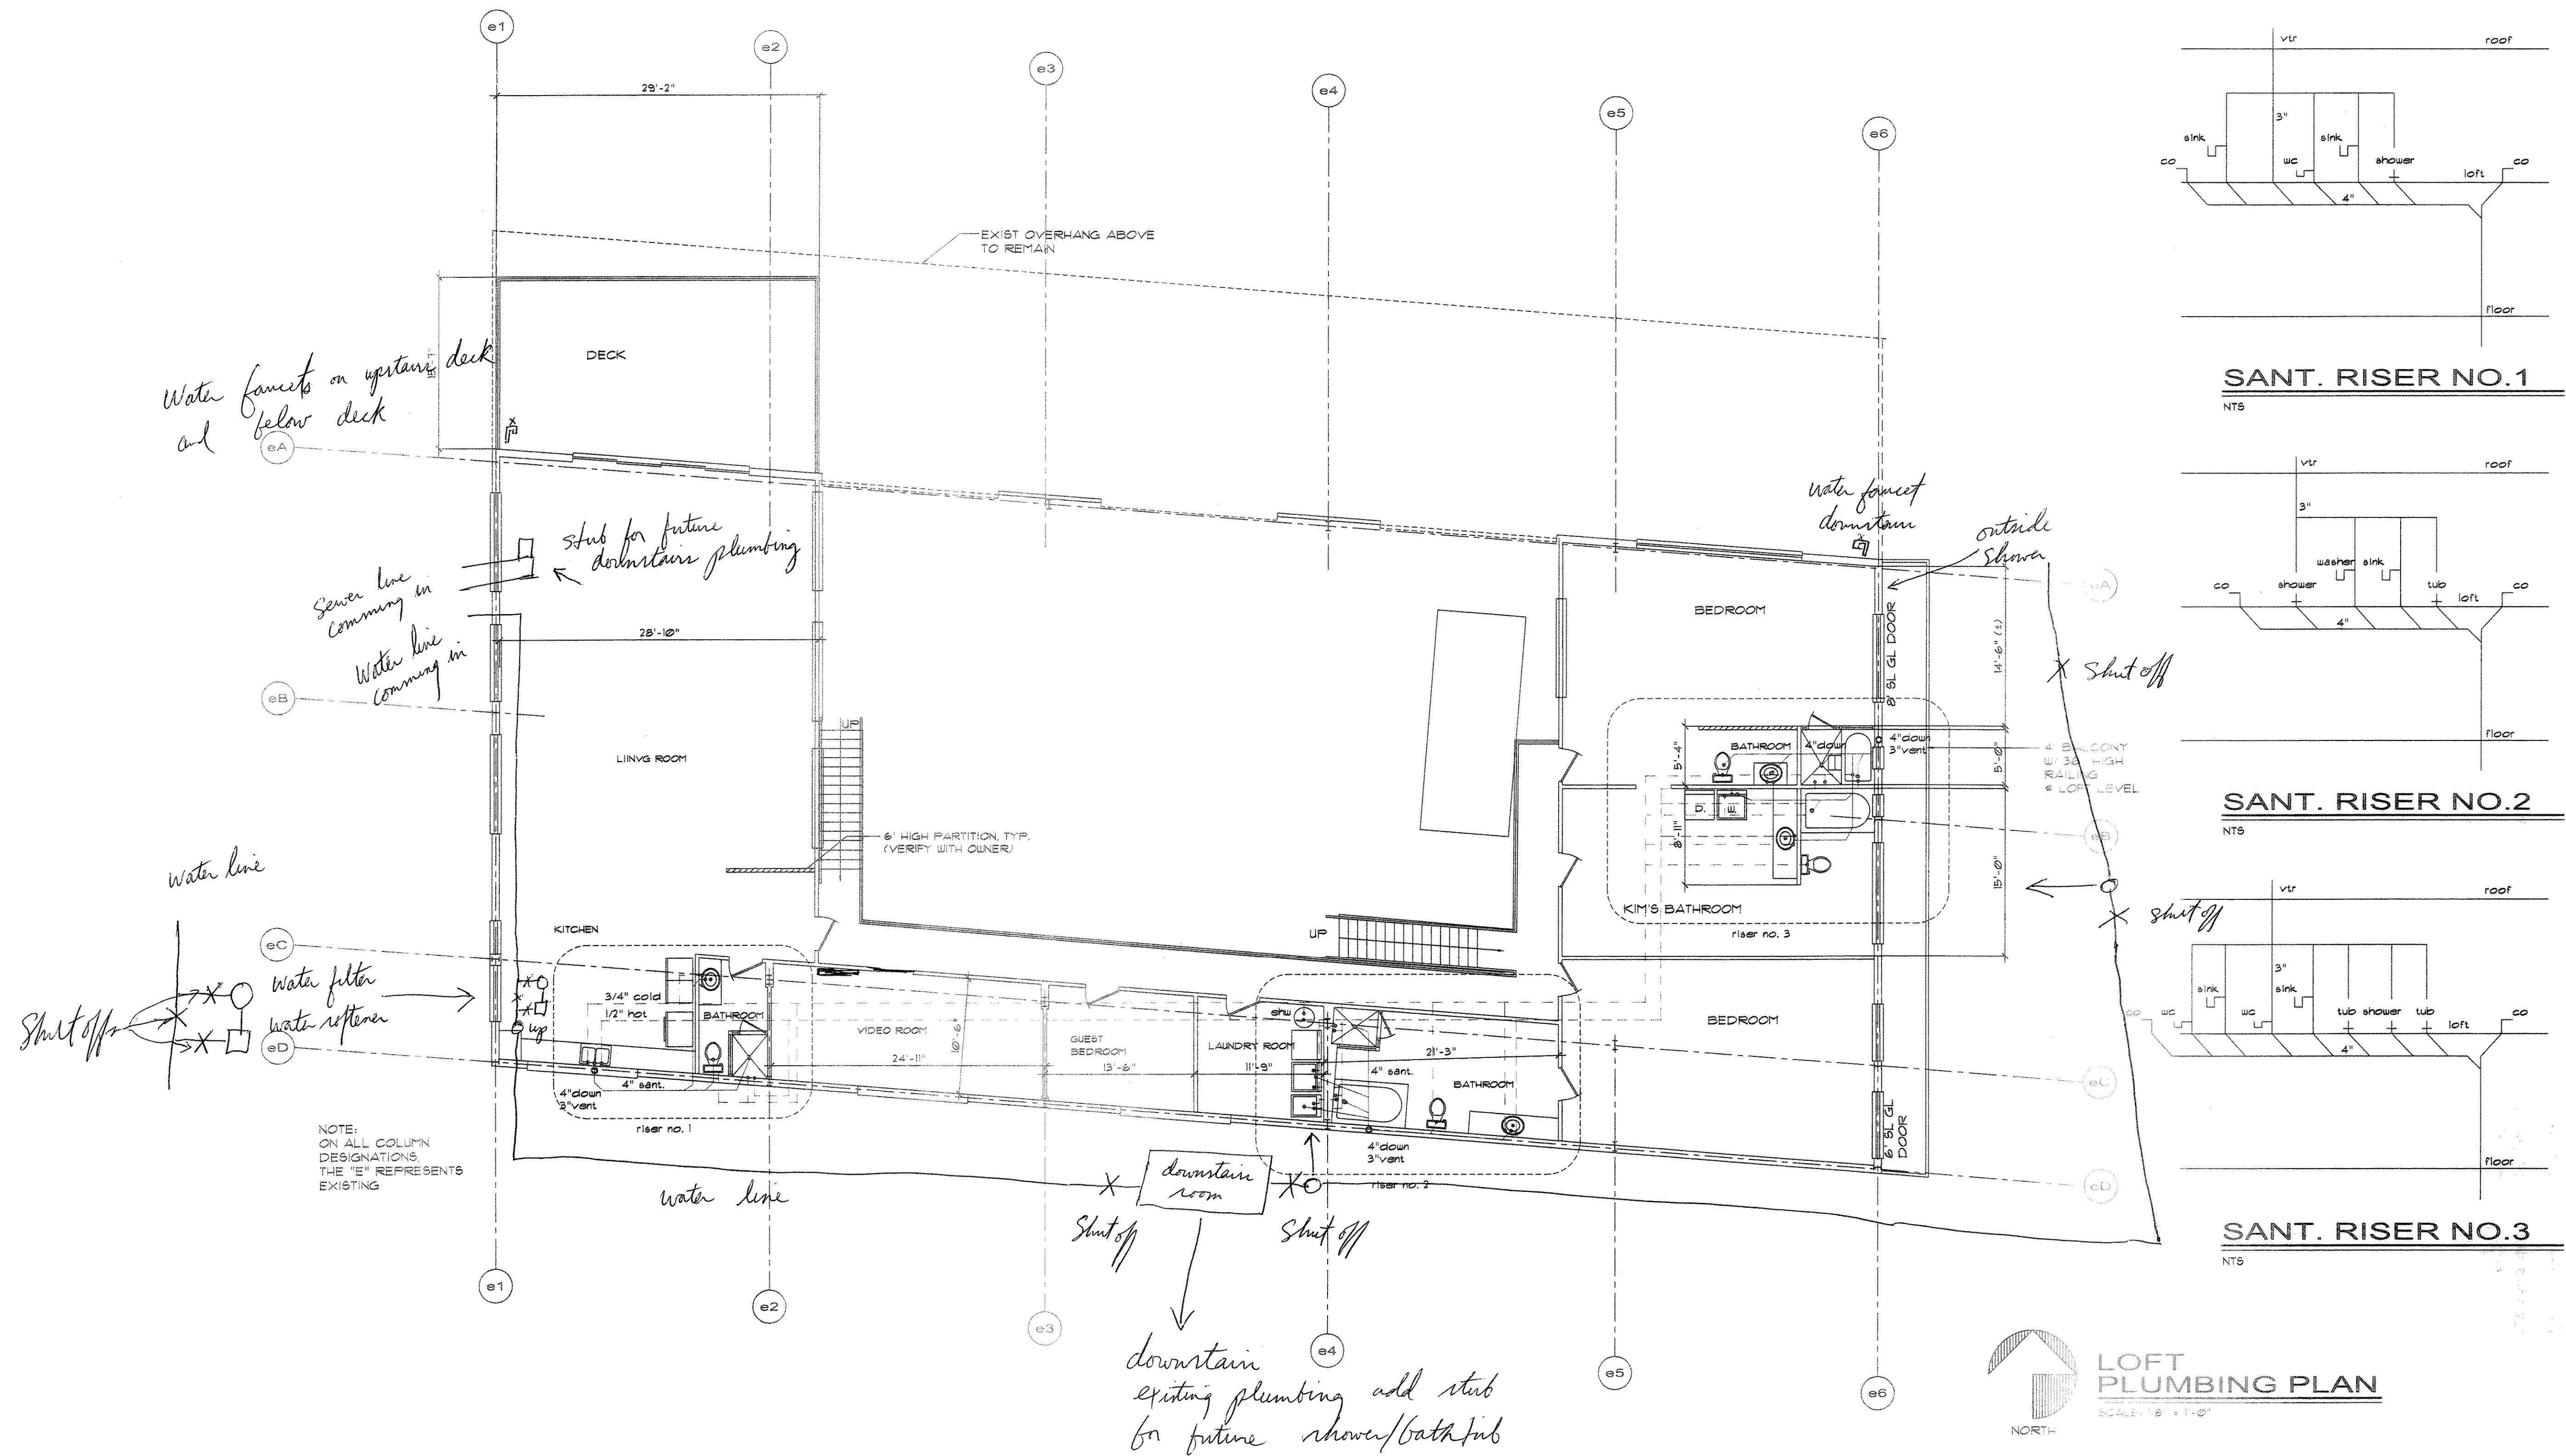

**LOFT
PLUMBING PLAN**
SCALE: 1/8" = 1'-0"